

GENERAL NOTES

A. SEE SHEET TA-001 FOR SYMBOL SCHEDULE AND GENERAL NOTES.



CONSULTANTS:

Issued For
CONSTRUCTION
06/06/2022
www.ssoe.com

SEAL ON THIS DOCUMENT AUTHORIZED BY:

APPLY STAMP IN
BLUE/BEAM

PROJECT INFORMATION:

**BROWNFIELD
MODIFICATIONS**

CLIENT INFORMATION:



**ASCEND
ELEMENTS**

ASCEND
ELEMENTS
9172 INDUSTRIAL DR NE
COVINGTON, GA
30014

CLIENT PROJECT NO: XXX-XXXXX-XX



NO.	DATE	SUBJECT
A	06/06/22	ISSUED FOR IFC

SSOE, Inc.
1001 Madison Avenue
Atlanta, GA 30304
T: (419) 255-3830

PROJECT NO: 021-01975-00
PROJECT MANAGER: R. FOX
DESIGNED: J. DELANEY
CHECKED: M. SMITH

DRAWING TITLE:
**FIRE ALARM OVERALL
FIRST FLOOR PLAN**

DRAWING NO:
TF-101

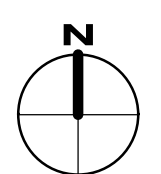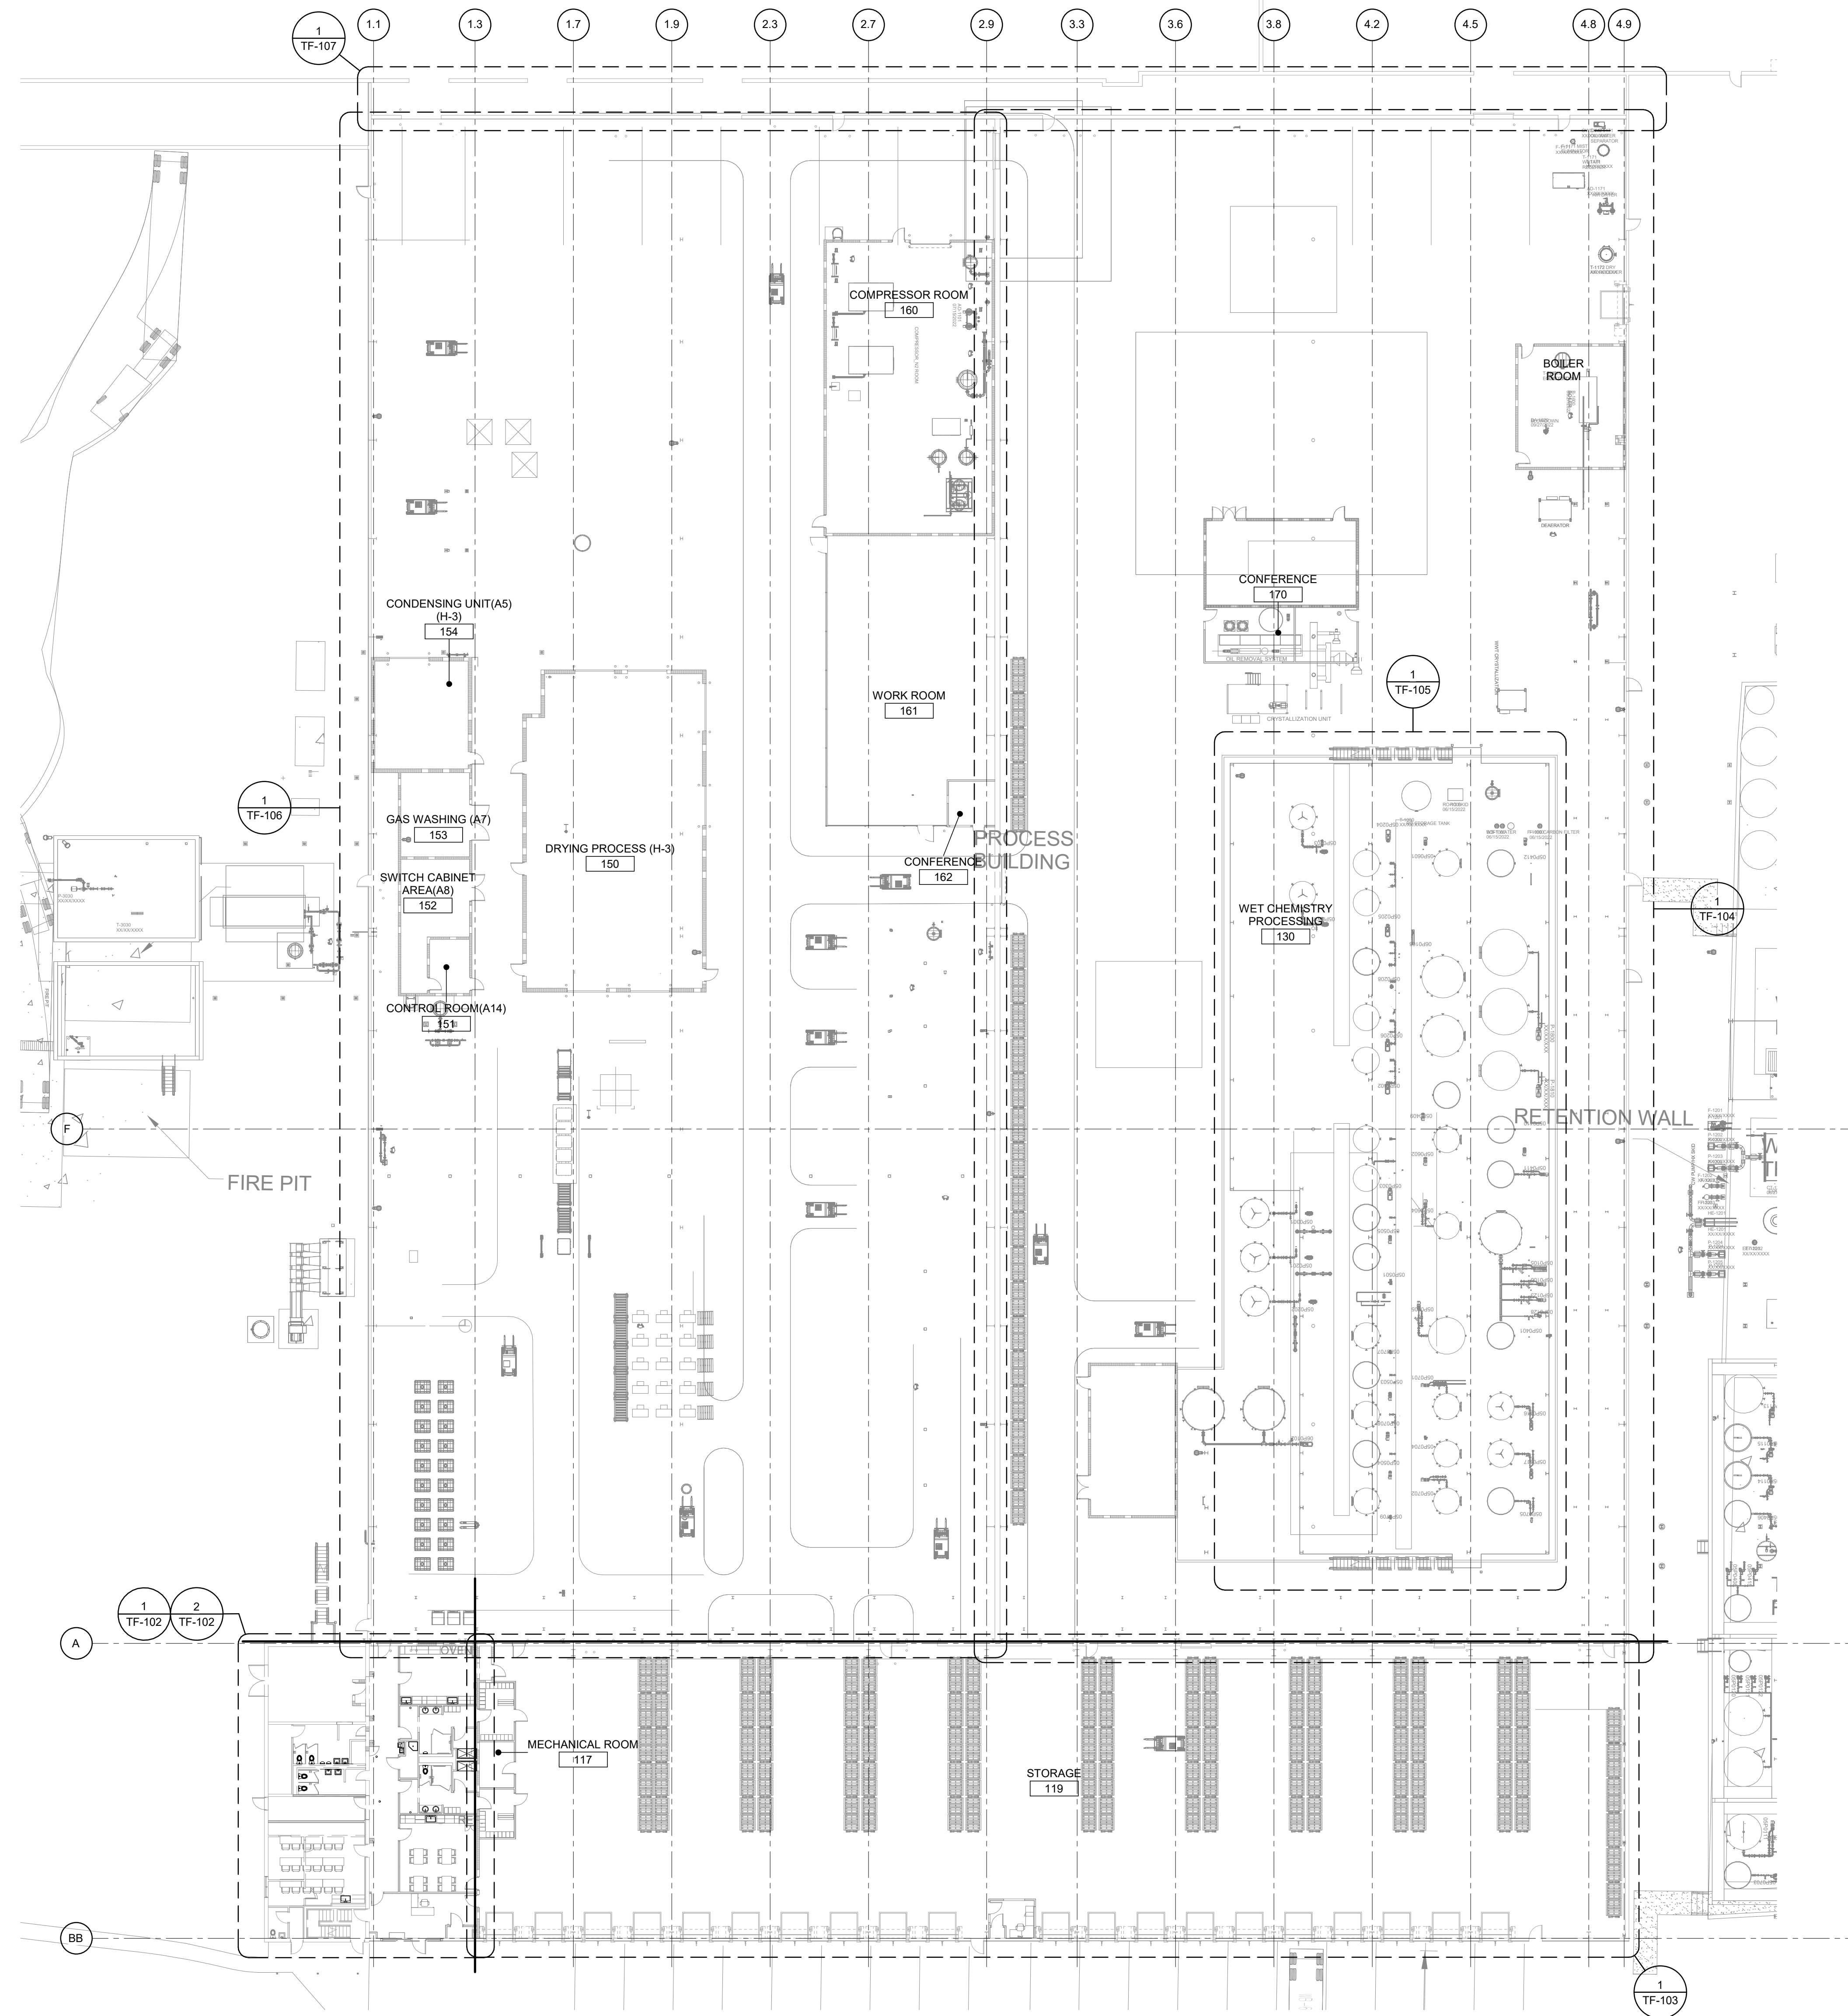

FIRE ALARM OVERALL FIRST FLOOR PLAN

SCALE: 3/8" = 1'-0"