

GENERAL NOTES

- A. SEE SHEET TA-001 FOR SYMBOL SCHEDULE AND GENERAL NOTES.
- B. UNLESS OTHERWISE NOTED, NOTIFICATION DEVICES IN THE WET PROCESS AREA ARE TO ONLY ACTIVATE UPON AN ALARM IN THE WET PROCESS AREA.

PLAN NOTES

- 1. MOUNT SPEAKER STROBE AT THE CEILING FOR MEZZANINE COVERAGE.

CONSULTANTS:

**Issued For
CONSTRUCTION**
 06/06/2022
 www.ssoe.com

SEAL ON THIS DOCUMENT AUTHORIZED BY:

APPLY STAMP IN
 BLUEBEAM

PROJECT INFORMATION:

**BROWNFIELD
MODIFICATIONS**


CLIENT INFORMATION:



**ASCEND
ELEMENTS**

**ASCEND
ELEMENTS**
 9172 INDUSTRIAL DR NE
 COVINGTON, GA
 30014

CLIENT PROJECT NO: XXX-XXXXX-XX

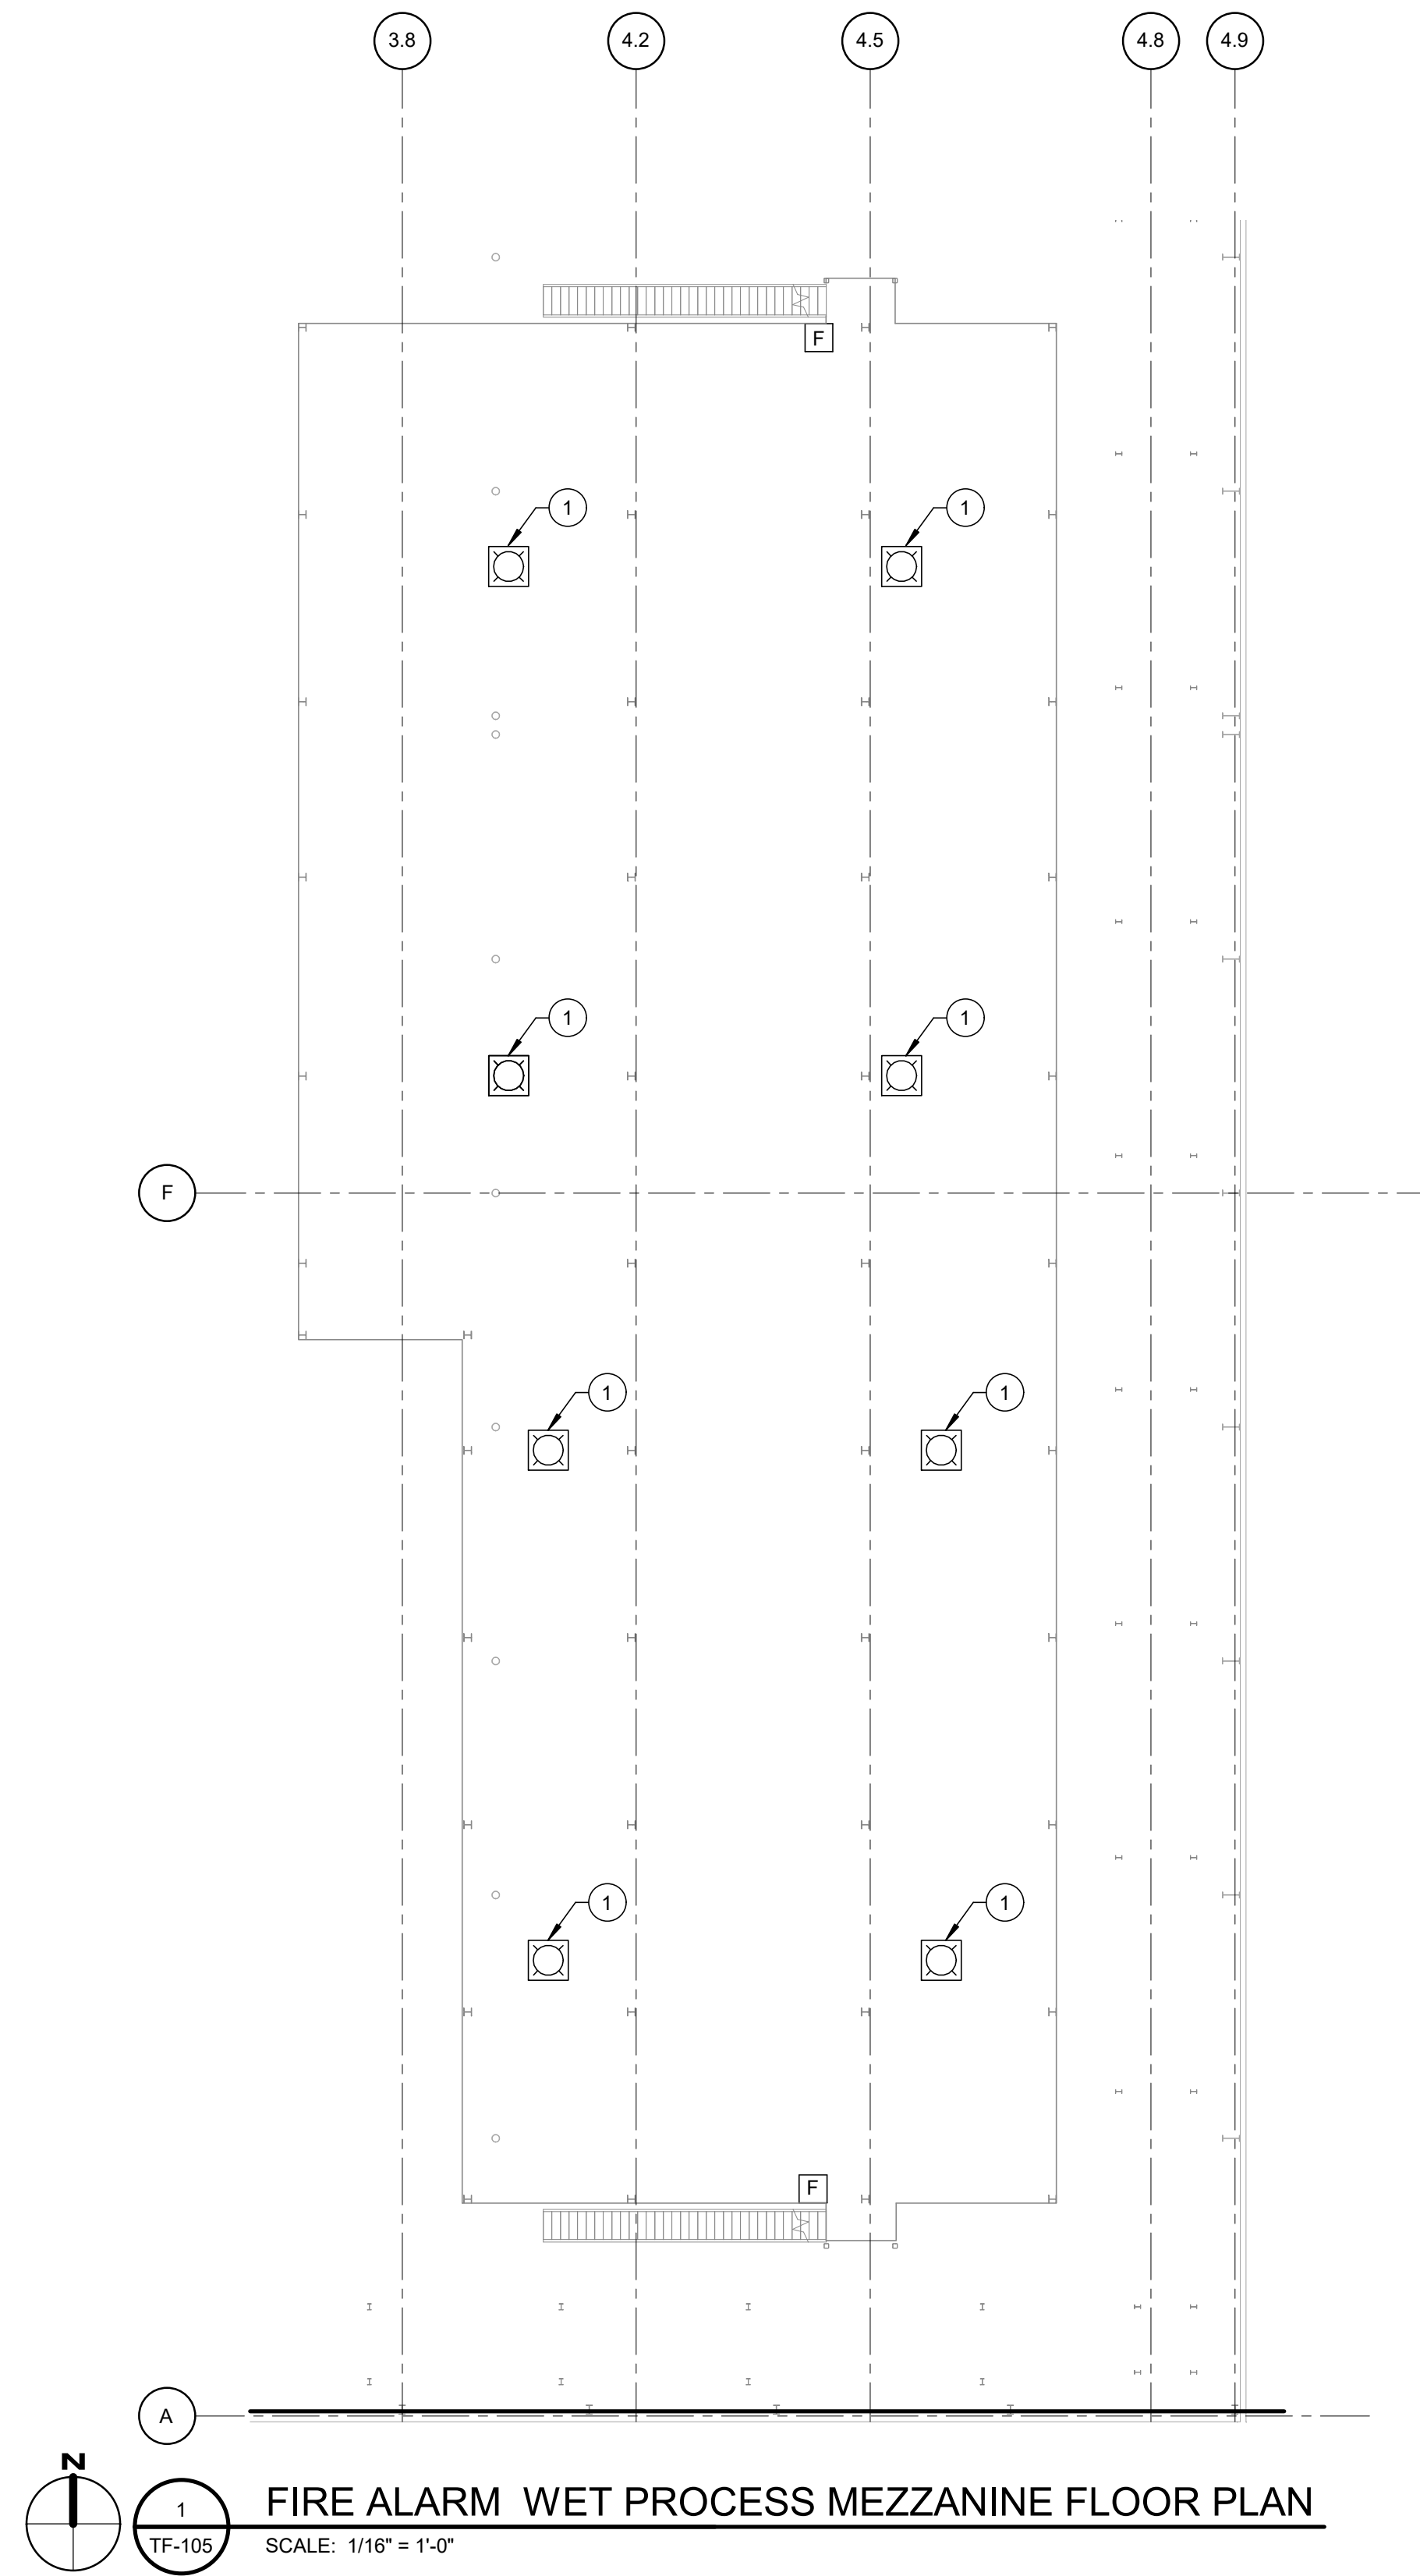

FIRE ALARM WET PROCESS MEZZANINE FLOOR PLAN
 SCALE: 1/16" = 1'-0"

NO.	DATE	SUBJECT
A	06/06/22	ISSUED FOR IFC

SSOE, Inc.
 1001 Madison Avenue
 Atlanta, GA 30304
 T: (419) 255-3830

PROJECT NO: **021-01975-00**
 PROJECT MANAGER: R. FOX
 DESIGNED: J. DELANEY
 CHECKED: M. SMITH

DRAWING TITLE:
**FIRE ALARM WET
 PROCESS MEZZANINE
 FLOOR PLAN**

DRAWING NO:
TF-105