

CONSULTANTS:

Issued For
CONSTRUCTION
05/04/2022
www.ssoe.com

GENERAL NOTES:

- A. REFER TO ARCHITECTURAL REFLECTED CEILING PLANS FOR EXACT LOCATION OF ALL LIGHTING FIXTURES UNLESS NOTED OTHERWISE.
- B. REFER TO THE LIGHTING FIXTURE SCHEDULE ON DRAWING EL-600.
- C. LIGHT SWITCHES SHALL BE GROUPED UNDER ONE COMMON FACEPLATE WHERE MORE THAN ONE LIGHT SWITCH IS INDICATED TO BE INSTALLED AT THE SAME LOCATION.
- D. ALL LIGHTING BRANCH CIRCUIT WIRING SHALL BE 2#12, 1#12GND IN 3/4" UNLESS NOTED OTHERWISE.
- E. ALL NIGHT LIGHT AND EXIT SIGNS SHALL BE UNCONTROLLED AND CONNECTED AHEAD OF THE LOCAL LIGHTING CONTROLS.
- F. ALL CONDUITS INSTALLED IN FINISHED AREAS SHALL BE ROUTED CONCEALED UNLESS NOTED OTHERWISE.
- G. ALL EXIT SIGN FIXTURES ARE TYPE 'X1' UNLESS NOTED OTHERWISE.

SEAL ON THIS DOCUMENT AUTHORIZED BY:



PROJECT INFORMATION:

BROWNFIELD MODIFICATIONS

CLIENT INFORMATION:

ASCEND ELEMENTS
ASCEND ELEMENTS
9172 INDUSTRIAL DR NE
COVINGTON, GA
30014

CLIENT PROJECT NO: XXX-XXXXX-XX


NO.	DATE	SUBJECT
B	05/03/22	FOR CONSTRUCTION - PKG 11E01
A	04/28/22	FOR PERMIT - PKG 11E01
NO.	DATE	SUBJECT
		REVISION OR ISSUE

SSOE, Inc.
1001 Madison Avenue
Tomball, TX 77364
T: (419) 255-3830

PROJECT NO: 021-01975-00
PROJECT MANAGER: R. FOX
DESIGNED: D. WOODS
CHECKED: F. ROWE

DRAWING TITLE:
FIRST FLOOR LIGHTING PLAN - COMPOSITE

DRAWING NO:
EL-110

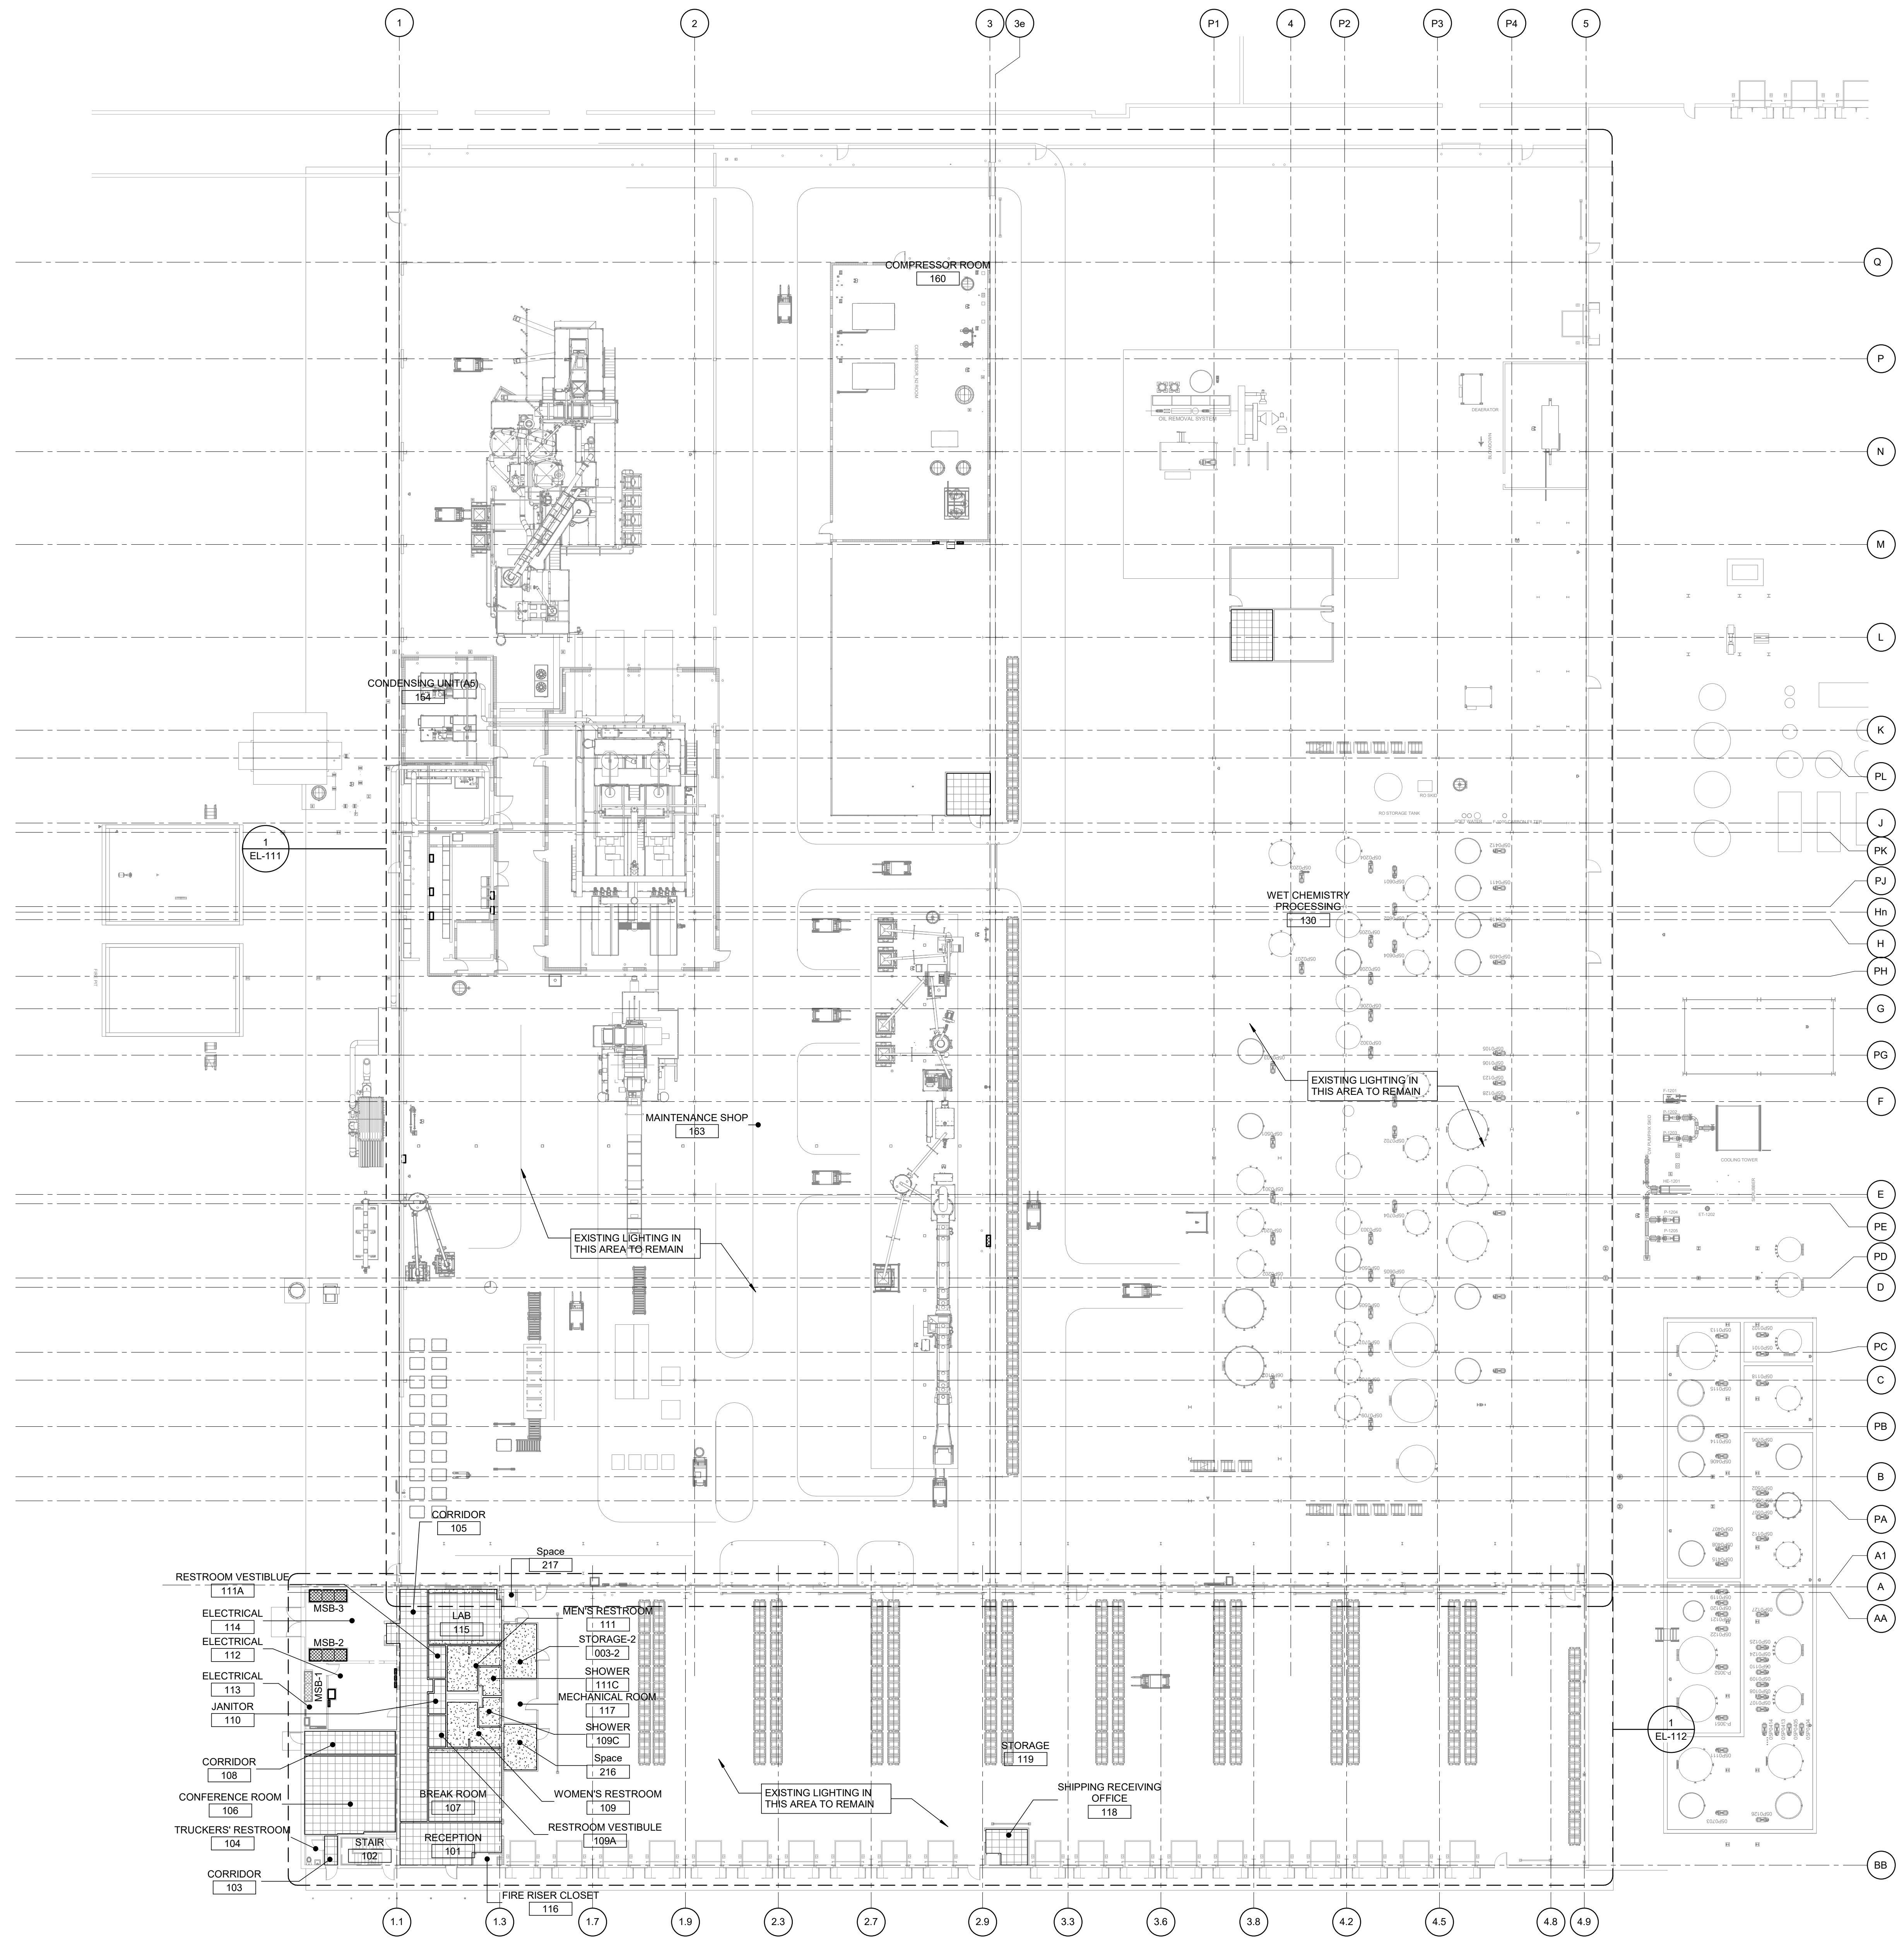

OVERALL FIRST FLOOR LIGHTING PLAN
SCALE: 1" = 20'-0"