


GENERAL NOTES:

- A. REFER TO ARCHITECTURAL REFLECTED CEILING PLANS FOR EXACT LOCATION OF ALL LIGHTING FIXTURES UNLESS NOTED OTHERWISE.
- B. REFER TO THE LIGHTING FIXTURE SCHEDULE ON DRAWING EL-600.
- C. LIGHT SWITCHES SHALL BE GROUPED UNDER ONE COMMON FACEPLATE WHERE MORE THAN ONE LIGHT SWITCH IS INDICATED TO BE INSTALLED AT THE SAME LOCATION.
- D. ALL LIGHTING BRANCH CIRCUIT WIRING SHALL BE 2#12, 1#12GND IN 3/4" UNLESS NOTED OTHERWISE.
- E. ALL NIGHT LIGHT AND EXIT SIGNS SHALL BE UNCONTROLLED AND CONNECTED AHEAD OF THE LOCAL LIGHTING CONTROLS.
- F. ALL CONDUITS INSTALLED IN FINISHED AREAS SHALL BE ROUTED CONCEALED UNLESS NOTED OTHERWISE.
- G. ALL EXIT SIGN FIXTURES ARE TYPE 'X1' UNLESS NOTED OTHERWISE.

CONSULTANTS:

**Issued For
CONSTRUCTION**
 05/04/2022
 www.ssoe.com

SEAL ON THIS DOCUMENT AUTHORIZED BY:

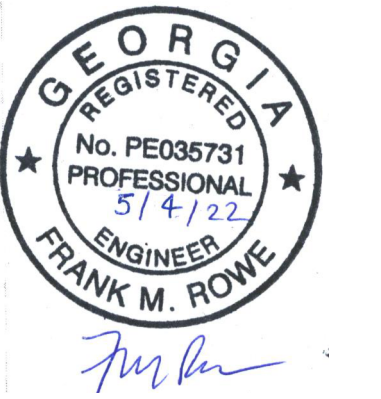

PROJECT INFORMATION:


**BROWNFIELD
MODIFICATIONS**

CLIENT INFORMATION:



**ASCEND
ELEMENTS**
 9172 INDUSTRIAL DR NE
 COVINGTON, GA
 30014

CLIENT PROJECT NO: XXX-XXXXX-XX

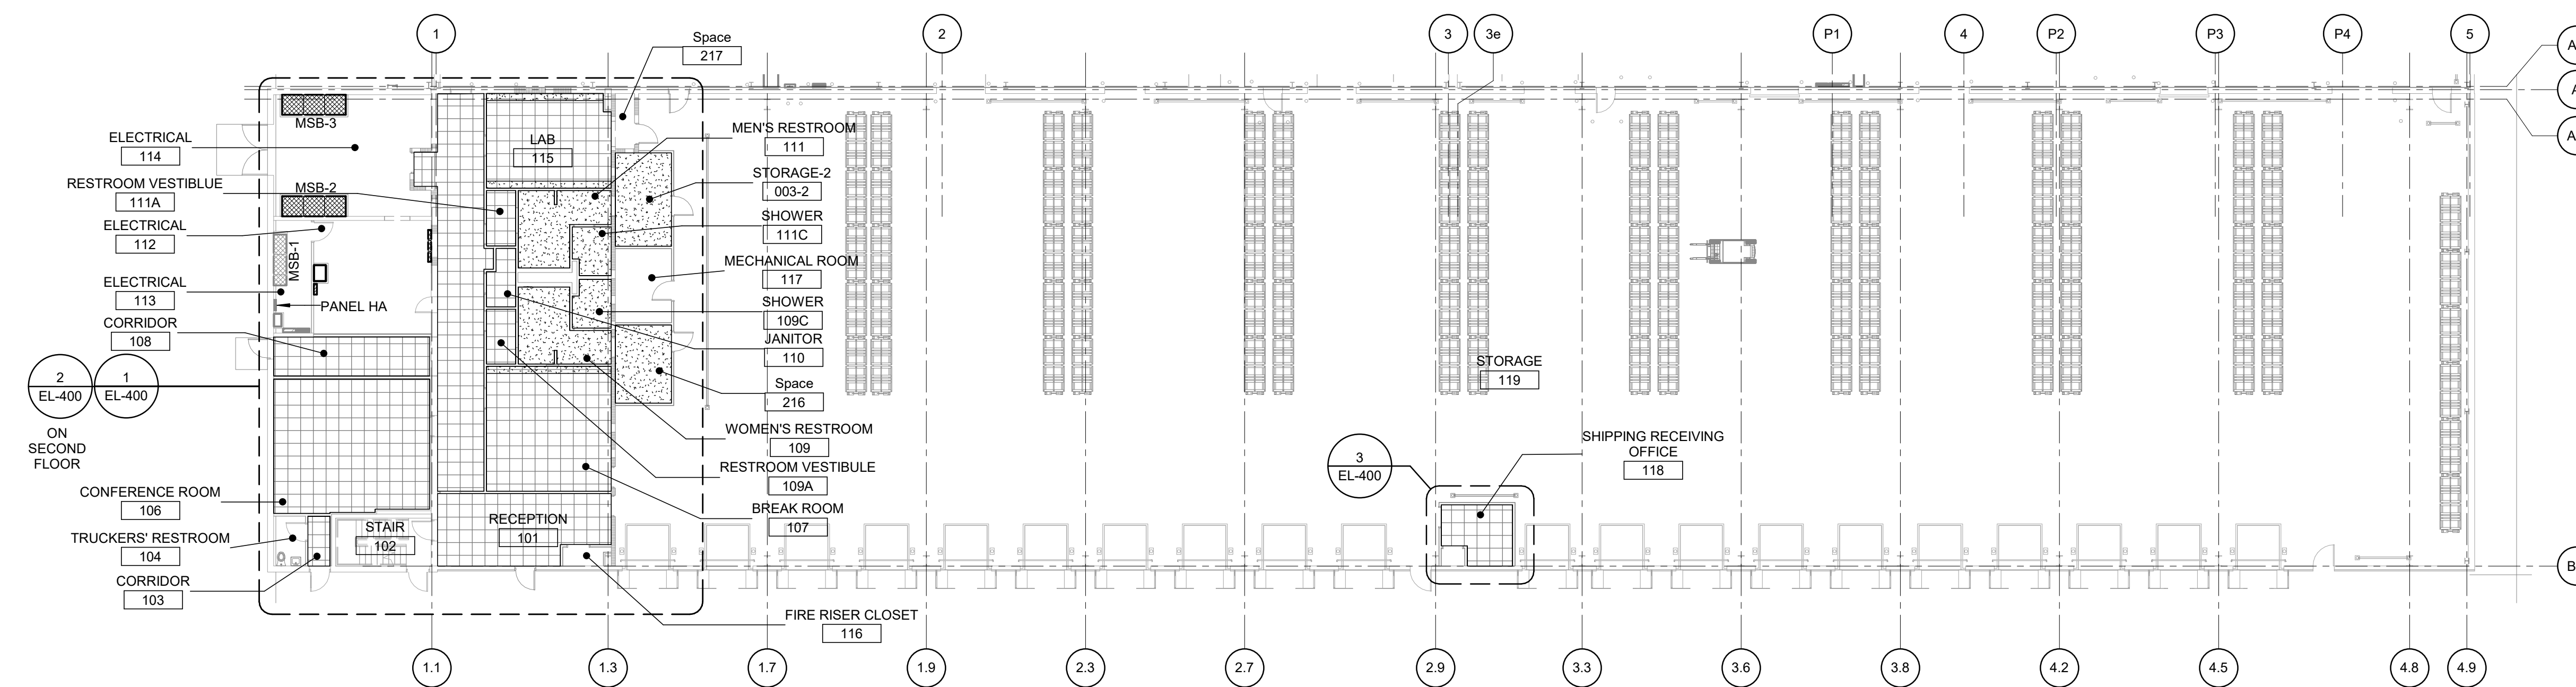

**FIRST FLOOR LIGHTING PLAN -
 SHIPPING RECEIVING AND
 OFFICE AREA**
 SCALE: 1/16" = 1'-0"

B	05/03/22	FOR CONSTRUCTION - PKG 11E01
A	04/28/22	FOR PERMIT - PKG 11E01
NO.	DATE	SUBJECT
REVISION OR ISSUE		

SSOE, Inc.
 1001 Madison Avenue
 Atlanta, GA 30304
 T: (419) 255-3830

PROJECT NO: **021-01975-00**
 PROJECT MANAGER: R. FOX
 DESIGNED: D. WOODS
 CHECKED: F. ROWE

DRAWING TITLE:
**FIRST FLOOR LIGHTING
 PLAN - SHIPPING REC. &
 OFFICE AREA**

DRAWING NO:
EL-112