

CONSULTANTS:

**Issued For CONSTRUCTION**  
 05/04/2022  
 www.ssoe.com

**GENERAL NOTES:**

- A. REFER TO ARCHITECTURAL FLOOR PLAN AND ELEVATIONS FOR EXACT LOCATION OF DEVICES WHERE INDICATED.
- B. ALL RECEPTACLE OUTLETS SHALL BE RATED 20A.
- C. ALL DISCONNECT SWITCHES SHALL BE HEAVY DUTY TYPE.
- D. PROVIDE GFCI PROTECTION WHERE REQUIRED BY THE NEC WHETHER INDICATED OR NOT.
- E. ALL BRANCH CIRCUIT JUNCTION BOXES SHALL BE LABELED WITH THE CIRCUITS ENCLOSED.
- F. REFER TO DRAWING EA-003 FOR CIRCUIT REQUIREMENTS.
- G. ALL CONDUITS SHALL BE ROUTED CONCEALED UNLESS NOTED OTHERWISE.
- H. ALL ELECTRICAL EQUIPMENT MOUNTED ON THE FLOOR SHALL BE MOUNTED ON A 4" CONCRETE HOUSEKEEPING PAD.
- J. REFER TO DRAWING EA-002 FOR ADDITIONAL GENERAL NOTES.

SEAL ON THIS DOCUMENT AUTHORIZED BY:



PROJECT INFORMATION:

**BROWNFIELD MODIFICATIONS**

CLIENT INFORMATION:



**ASCEND ELEMENTS**  
 9172 INDUSTRIAL DR NE  
 COVINGTON, GA  
 30014

CLIENT PROJECT NO: XXX-XXXX-XX

C	05/03/22	FOR CONSTRUCTION - PKG 11E01
B	04/28/22	FOR PERMIT - PKG 11E01
A	04/12/22	FOR CONSTRUCTION - PKG 12E01


NO.	DATE	SUBJECT

**SSOE, Inc.**  
 1001 Madison Avenue  
 Atlanta, GA 30304  
 T: (419) 255-3830

PROJECT NO: 021-01975-00  
 PROJECT MANAGER: R. FOX  
 DESIGNED: D. WOODS  
 CHECKED: F. ROWE

DRAWING TITLE:  
**FIRST FLOOR POWER PLAN - COMPOSITE**

DRAWING NO:  
**EP-110**

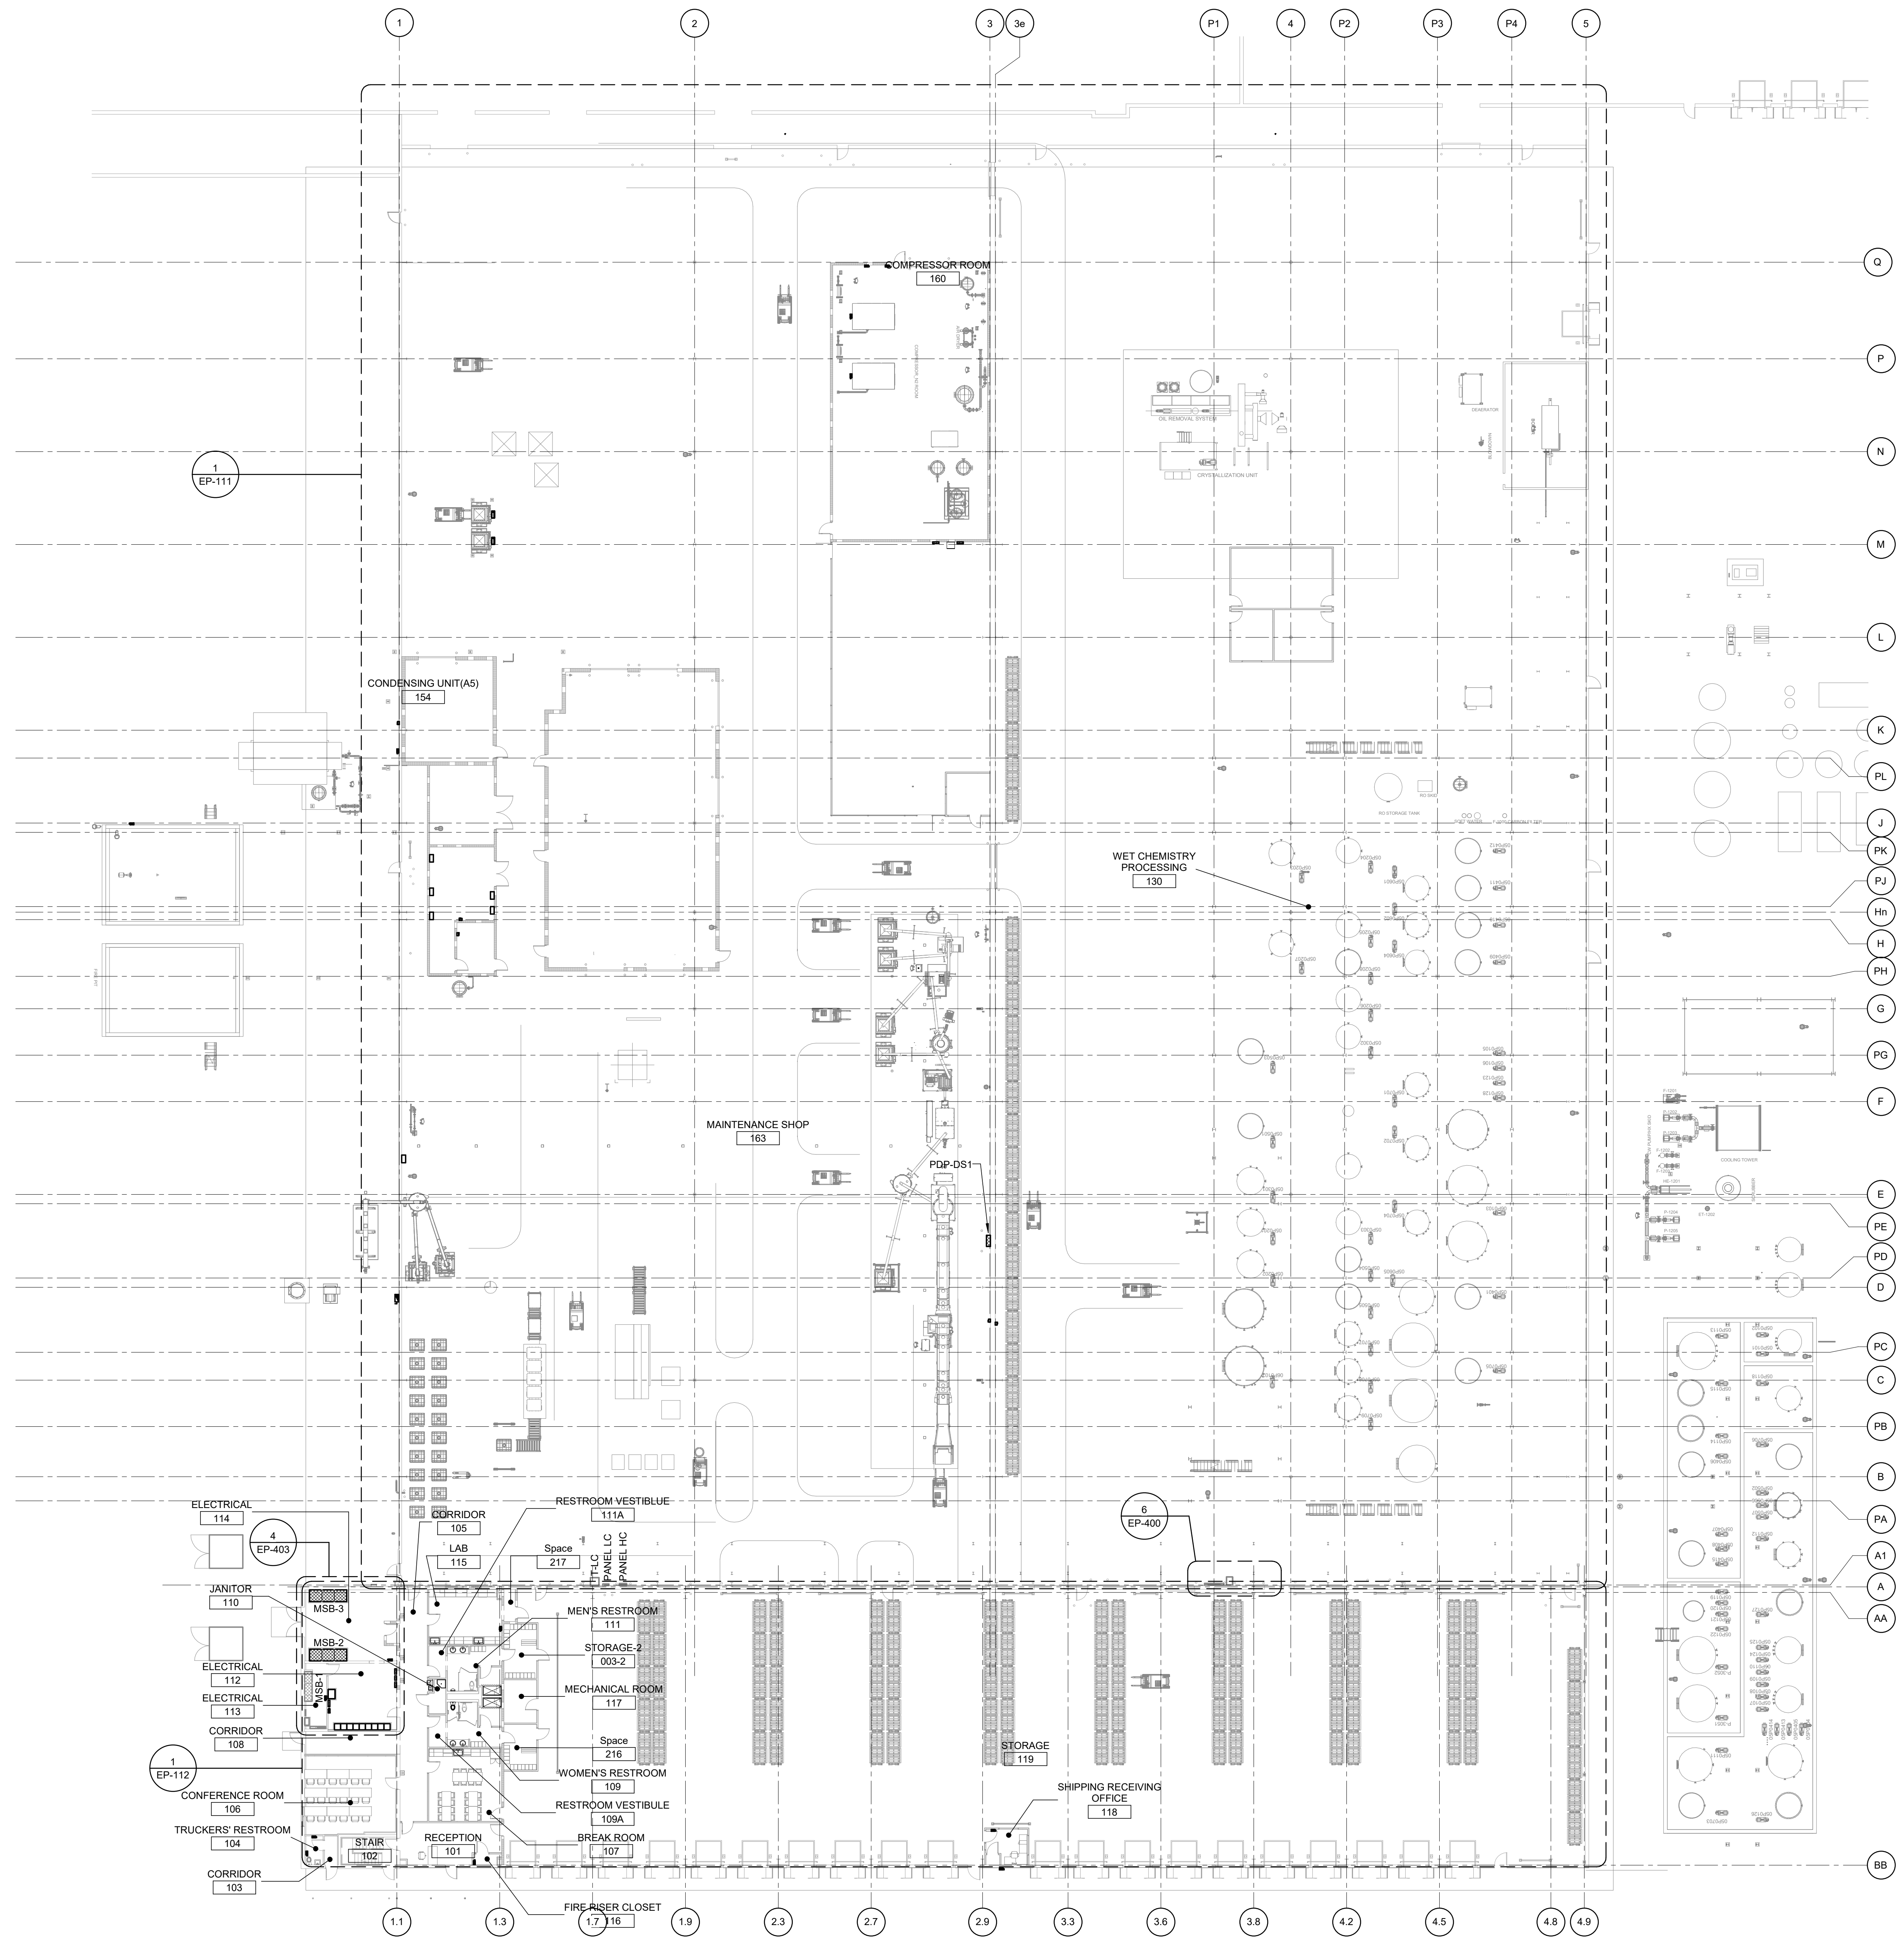

**OVERALL FIRST FLOOR POWER PLAN**  
 SCALE: 1" = 20'-0"