

GENERAL NOTES:

- A. REFER TO ARCHITECTURAL FLOOR PLAN AND ELEVATIONS FOR EXACT LOCATION OF DEVICES WHERE INDICATED.
- B. ALL RECEPTACLE OUTLETS SHALL BE RATED 20A.
- C. ALL DISCONNECT SWITCHES SHALL BE HEAVY DUTY TYPE.
- D. PROVIDE GFCI PROTECTION WHERE REQUIRED BY THE NEC WHETHER INDICATED OR NOT.
- E. ALL BRANCH CIRCUIT JUNCTION BOXES SHALL BE LABELED WITH THE CIRCUITS ENCLOSED.
- F. REFER TO DRAWING EA-003 FOR CIRCUIT REQUIREMENTS.
- G. ALL CONDUITS SHALL BE ROUTED CONCEALED UNLESS NOTED OTHERWISE.
- H. ALL ELECTRICAL EQUIPMENT MOUNTED ON THE FLOOR SHALL BE MOUNTED ON A 4" CONCRETE HOUSEKEEPING PAD.
- J. REFER TO DRAWING EA-002 FOR ADDITIONAL GENERAL NOTES.

**Issued For
BULLETIN**
 07/22/2022
 www.ssoe.com

SEAL ON THIS DOCUMENT AUTHORIZED BY:

APPLY STAMP IN
 BLUEBEAM

PROJECT INFORMATION:

**BROWNFIELD
MODIFICATIONS**

CLIENT INFORMATION:



**ASCEND
ELEMENTS**
 9172 INDUSTRIAL DR NE
 COVINGTON, GA
 30014

CLIENT PROJECT NO: XXX-XXXXX-XX


C	07/22/22	BULLETIN 2- PKG 11E01
B	05/03/22	FOR CONSTRUCTION - PKG 11E01
A	04/28/22	FOR PERMIT - PKG 11E01
NO.	DATE	SUBJECT
REVISION OR ISSUE		

SSOE, Inc.
 1001 Madison Avenue
 Duluth, GA 30094
 T. (419) 255-3830

PROJECT NO: **021-01975-00**
 PROJECT MANAGER: R. FOX
 DESIGNED: D. WOODS
 CHECKED: F. ROWE

DRAWING TITLE:
**FIRST FLOOR POWER
 PLAN - SHIPPING REC. &
 OFFICE AREA**

DRAWING NO:
EP-112

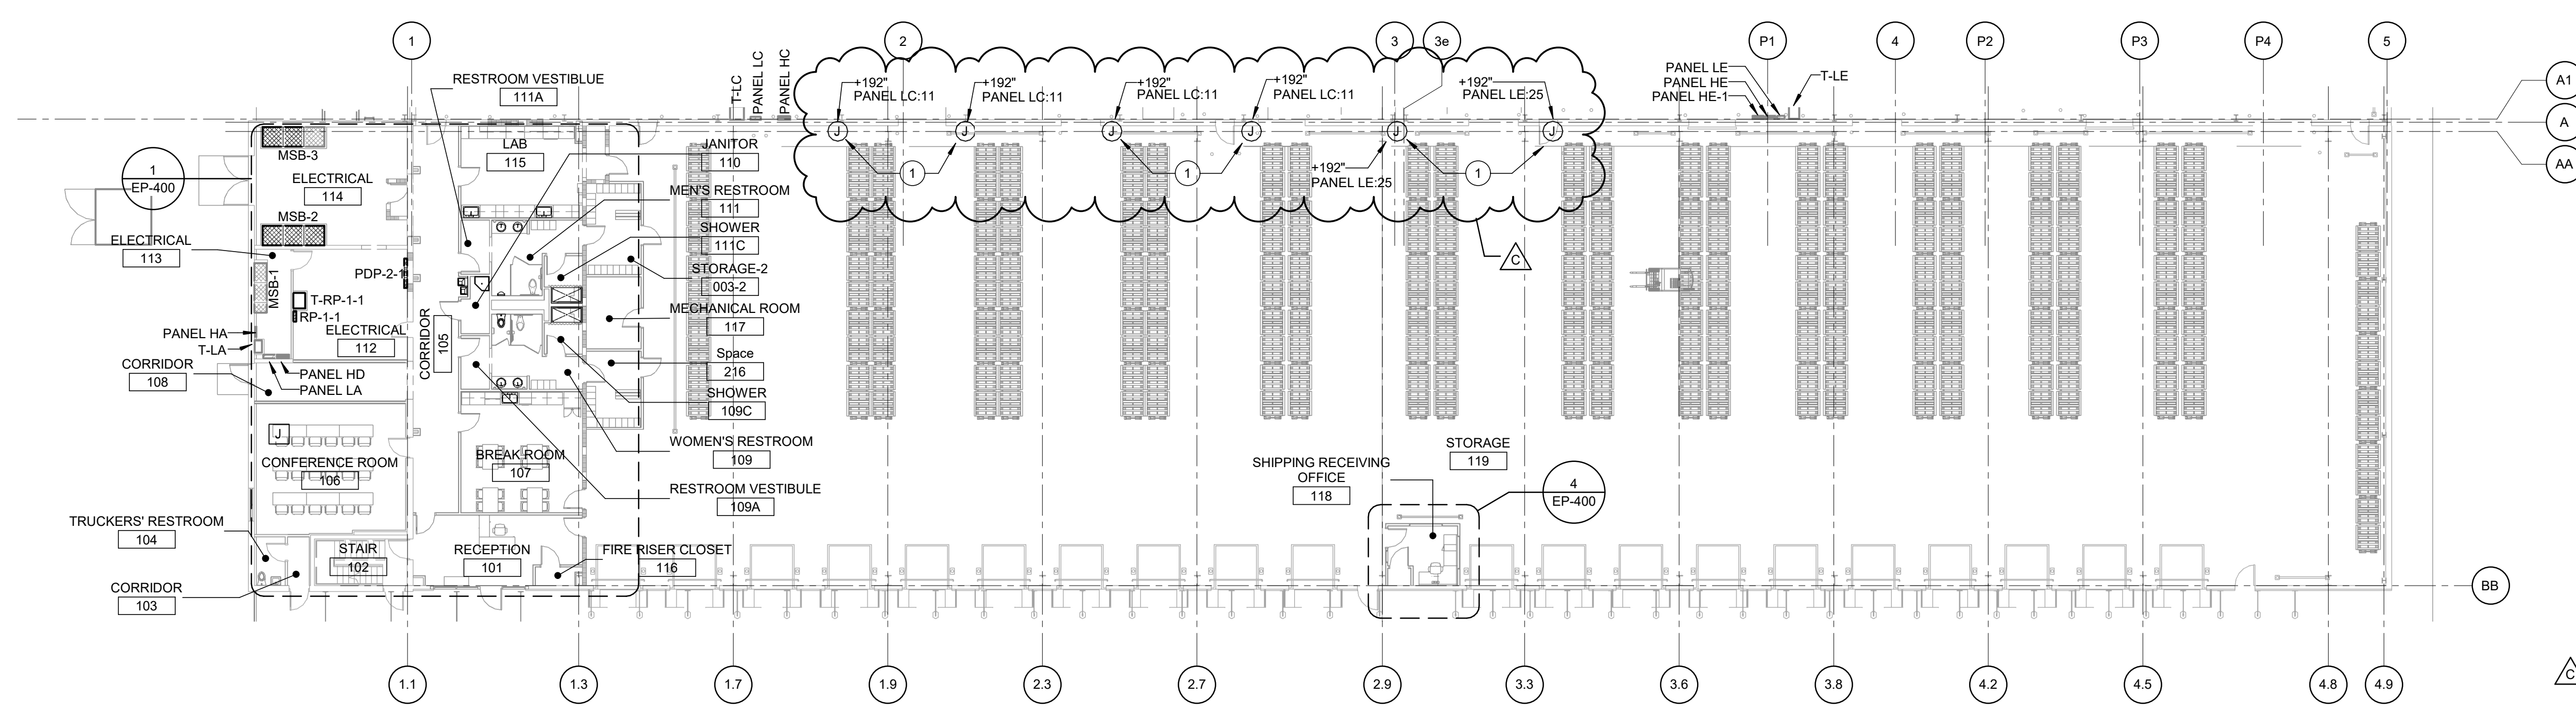

NOTES:
 1. PRIOR TO INSTALLATION FIELD COORDINATE MOUNTING LOCATION WITH IN-RACK SMOKE AND HYDROGEN DETECTION DETAIL ON FIRE ALARM STORAGE DRAWING TF-103.

**FIRST FLOOR POWER PLAN -
 SHIPPING RECEIVING AND
 OFFICE AREA**
 SCALE: 1/16" = 1'-0"