


CONSULTANTS:

Issued For CONSTRUCTION
04/28/2022
www.ssoe.com

SEAL ON THIS DOCUMENT AUTHORIZED BY:

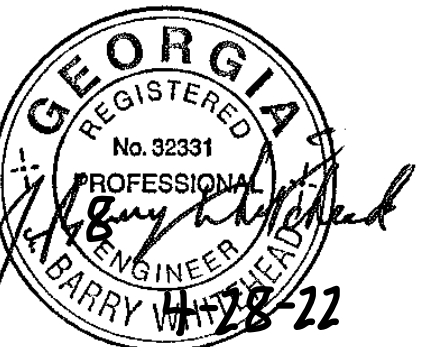

PROJECT INFORMATION:

BROWNFIELD MODIFICATIONS

CLIENT INFORMATION:



ASCEND ELEMENTS
ASCEND ELEMENTS
9172 INDUSTRIAL DR NE
COVINGTON, GA
30014

CLIENT PROJECT NO: XXX-XXXXX-XX


NO.	DATE	SUBJECT

SSOE, Inc.
1001 Madison Avenue
Atlanta, GA 30304
T: (419) 255-3830


PROJECT NO: 021-01975-00
PROJECT MANAGER: R. FOX
DESIGNED: I. SUGGALA
CHECKED: B. WHITEHEAD

DRAWING TITLE:
OVERALL HVAC ROOF PLAN

DRAWING NO:
MH-101

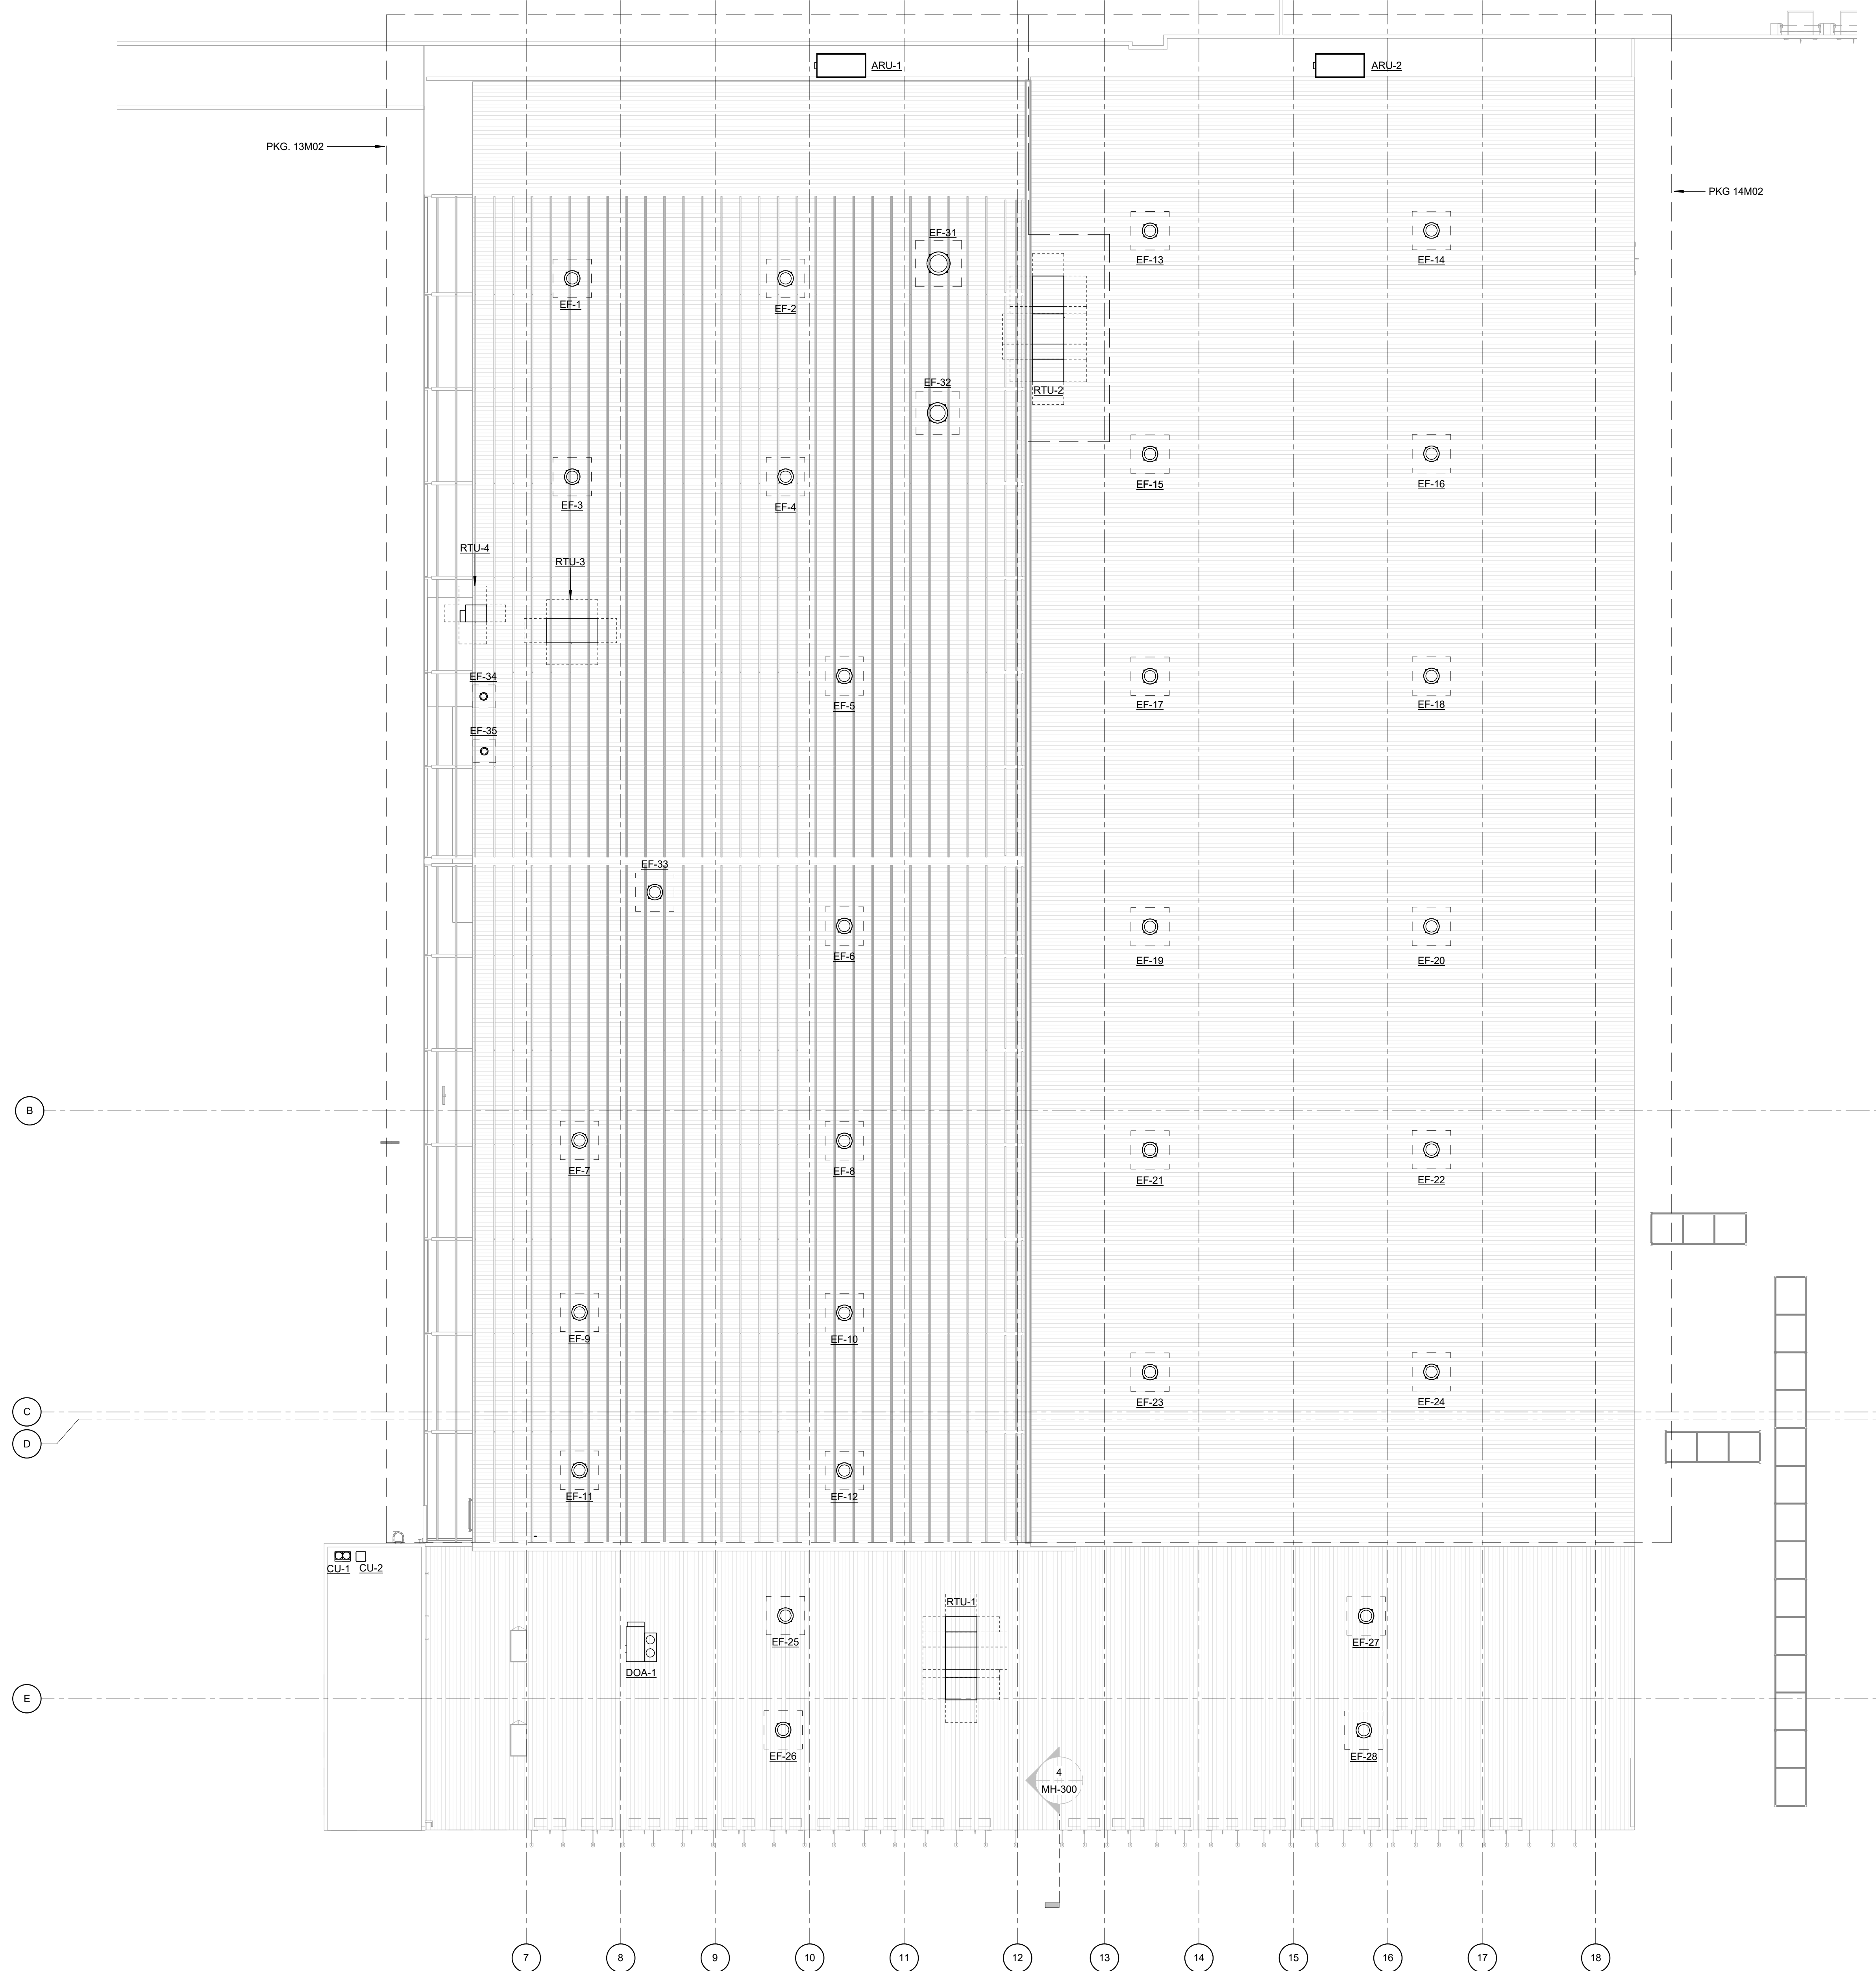

OVERALL HVAC ROOF PLAN
SCALE: 1" = 20'-0"

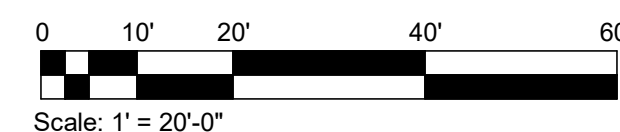

*THIS SHEET IS APPLICABLE TO 11M01, 13M02 AND 14M02 SCOPE
*DASHED AREAS ARE NOT IN SCOPE FOR THIS PACKAGE.