



10641 Highway 36
Covington, GA
30014


www.sunbeltbuilders.com

t 770.786.3031
f 770.786.3046

HISTORIC JAIL RENOVATIONS

Legacy Electrical Services
2421 Lance Ct.
Suite C
Loganville, GA 30052
ph: 470-545-2130
Mark Staples
mark@legacyesi.com

26-0000 Electrical As-built

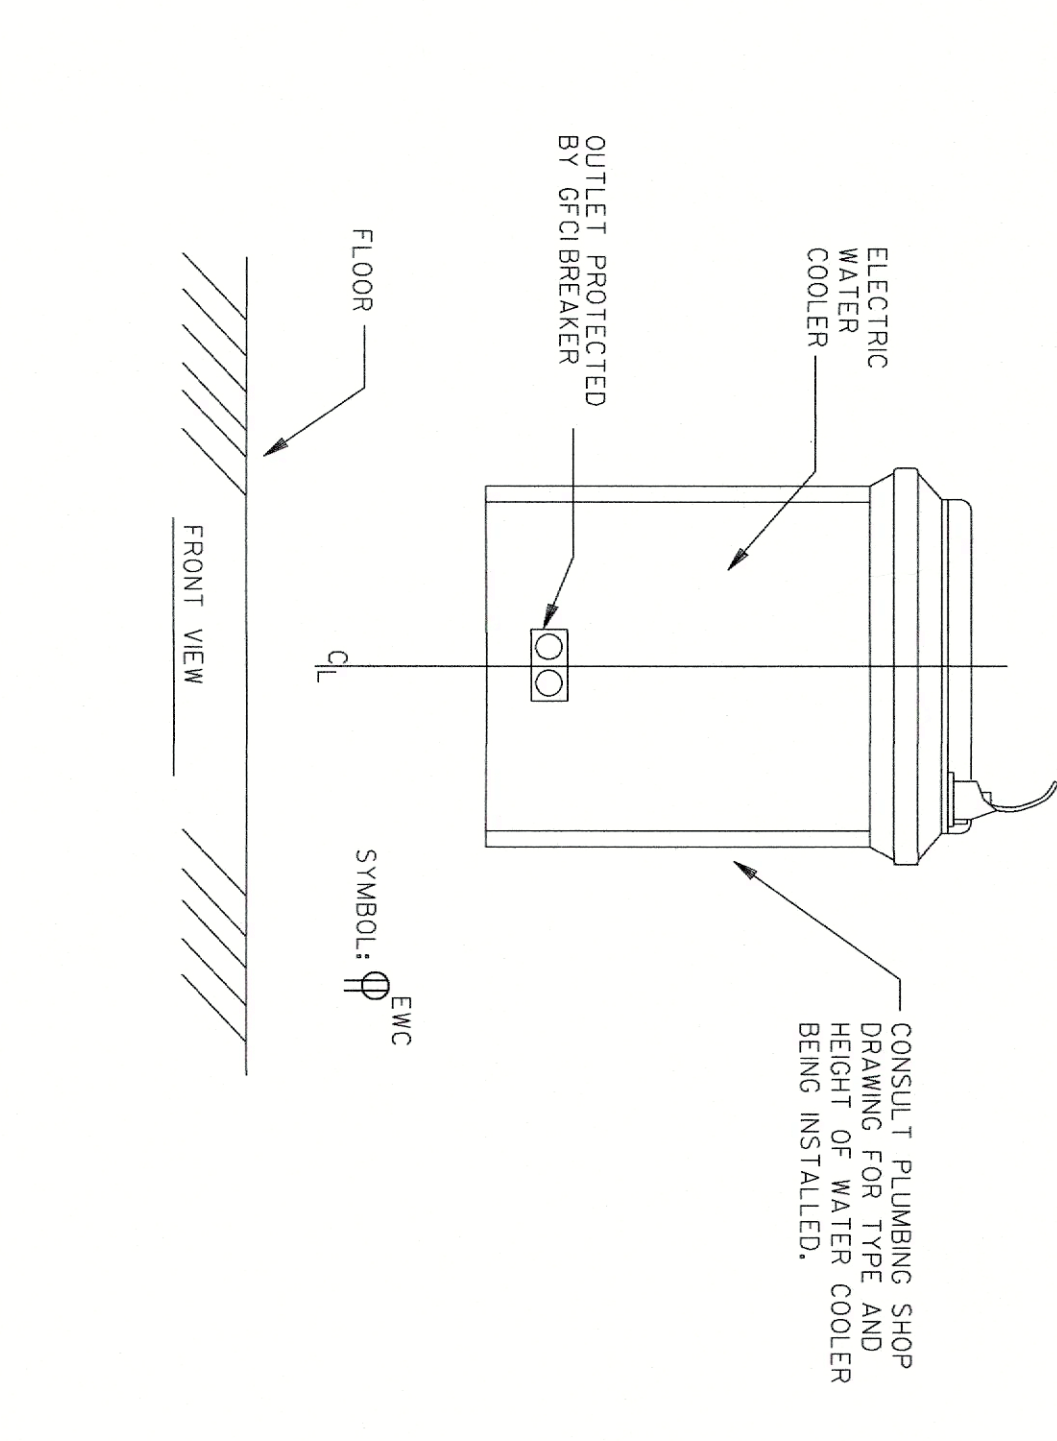

3
E-41

CABLE CONNECTION TO STEEL BEAM


NOT TO SCALE



5
E-4.1

TYPICAL EXIT LIGHT MOUNTING DETAIL


NOT TO SCALE

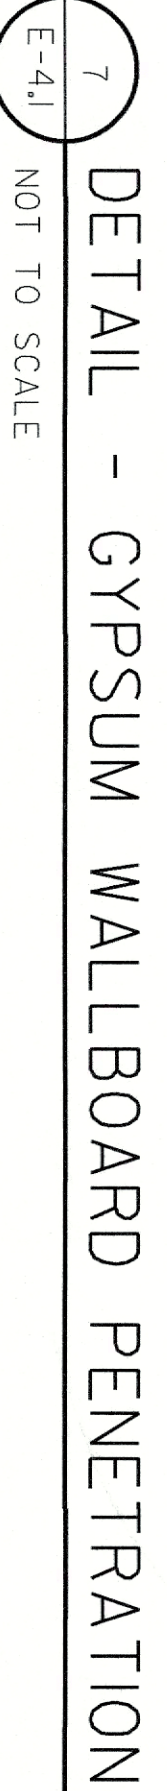

8
E-41

DETAIL - CONCRETE WALL PENETRATION

NOT TO SCALE

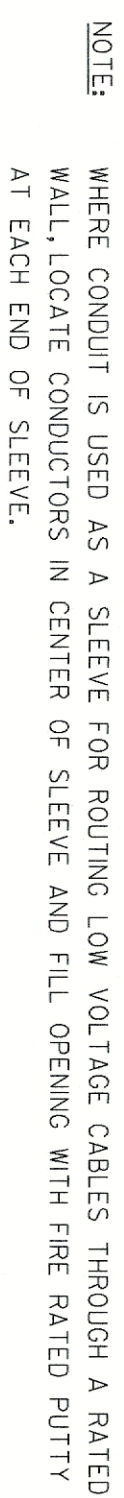

8
E-41

DETAIL - CONCRETE WALL PENETRATION

NOT TO SCALE

[illegible][illegible]

POWER RISER DIAGRAM
NOT TO SCALE
E-4.1

☐ MAIN SERVICE PANELS. PROVIDE 5-# CONDUCTORS IN 1" C-FROM 60A/3P BREAKER IN SUPPLYING PANEL. PROVIDE BREAKER, UL#449 LISTED, 200,000 SURGE CURRENT RATING, SERVICE ENTRANCE RATED, EATON EXTERNALLY MOUNTED SPD SERIES OR EQUAL.

KEYED NOTES: (THIS SHEET ONLY)

- [illegible]

Outdoor Lighting Insects

Sheet Title
POWER RISER
DIAGRAM, DETAILS, &
SCHEDULES



CONSULTANTS, INC.
175 NEW ST., STE. 1
MACON, GA 31201
EDC • M24029

ELECTRICAL DESIGN

CONSULTANTS, INC.

175 NEW ST., STE. 1
MACON, GA 31201
EDC • M24029



208 Pirkle Ferry Road, Suite C
Cumming, GA 30040